




TARLAC STATE UNIVERSITY
Facilities Development and Management Office
 Romulo Boulevard, Tarlac City, Philippines 2300

PROJECT TITLE:	REQUESTING OFFICE:	REVIEWED BY:	RECOMMENDING APPROVAL:	RECOMMENDING APPROVAL:	APPROVED:	CHECKED:	SHEET CONTENTS:	SHEET NO.:
PROJECT LOCATION:	DR. MARY JANE N. RIGOR DEAN, COS	ENGR. RYAN M. LAYUG FDMO-PMU, HEAD	AR. FERDINAND S. VALENCIA FMDO, DIRECTOR	DR. MARLON V. GAMIDO VP ADMIN AND FINANCE	DR. MYRNA Q. MALLARI PRESIDENT	AR. FERDINAND S. VALENCIA ARCHITECTURAL	AS SHOWN	
COLLEGE OF SCIENCE, LUCINDA EXTENSION CAMPUS						MR. MARK ANTHONY PUNZALAN DRAFTSMAN	DATE: OCTOBER 2021	PAGE NO.:




TARLAC STATE UNIVERSITY
 Facilities Development and
 Management Office
 Romulo Boulevard, Tarlac City, Philippines 2300


PROJECT TITLE:	REQUESTING OFFICE:	REVIEWED BY:	RECOMMENDING APPROVAL:	RECOMMENDING APPROVAL:	APPROVED:	CHECKED:	SHEET CONTENTS:	SHEET NO.:
PROJECT LOCATION:	DR. MARY JANE N. RIGOR DEAN, COS	ENGR. RYAN M. LAYUG FDMO-PMU, HEAD	AR. FERDINAND S. VALENCIA FMDO, DIRECTOR	DR. MARLON V. GAMIDO VP ADMIN AND FINANCE	DR. MYRNA Q. MALLARI PRESIDENT	AR. FERDINAND S. VALENCIA ARCHITECTURAL	AS SHOWN	
COLLEGE OF SCIENCE, LUCINDA EXTENSION CAMPUS						MR. MARK ANTHONY PUNZALAN DRAFTSMAN	DATE: OCTOBER 2021	PAGE NO.:

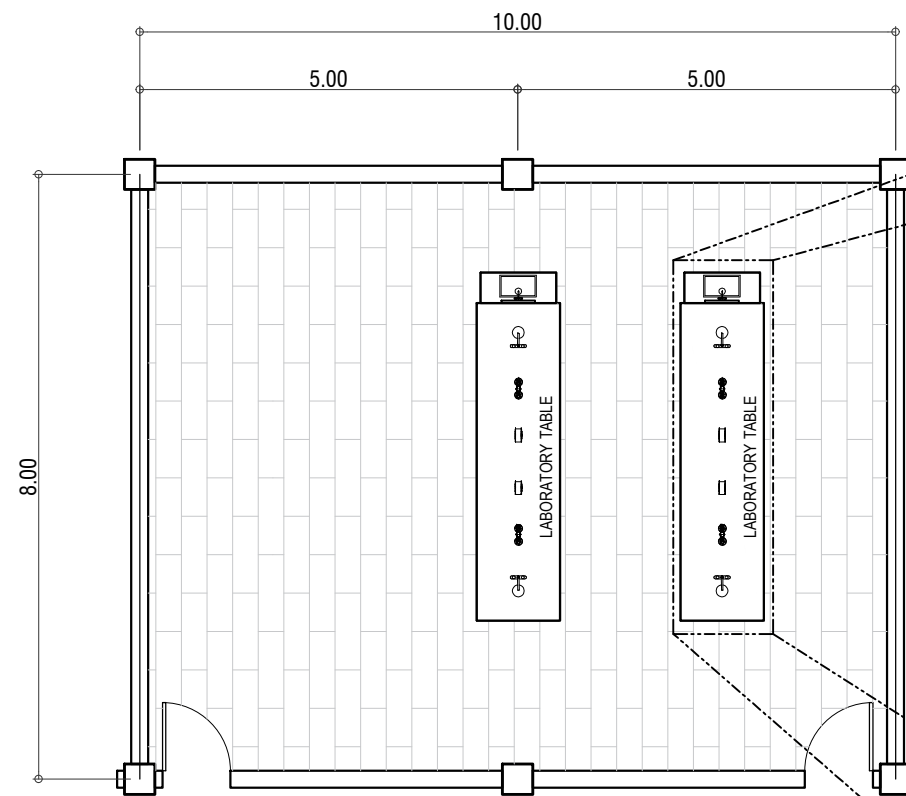

L.S 8 FLOOR PLAN
SCALE 1:100 MTS

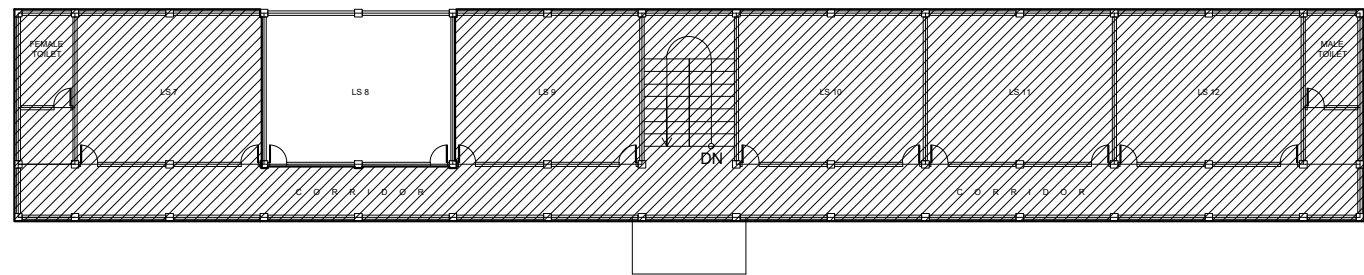


KEY PLAN
SCALE 1:400 MTS

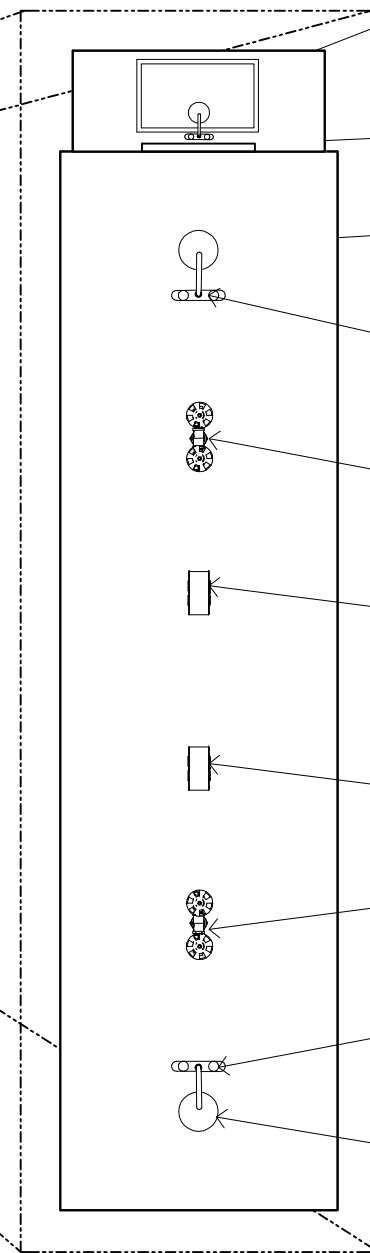


TYPICAL LABORATORY TABLE BLOW UP PLAN
SCALE 1:30 MTS

- END SINK WITH COMPLETE SET OF ACID-RESISTANT P-TRAP AND DRAIN WITH SINK CABINET WITH CONCEALED HINGE SWING DOORS
- PEG BOARD WITH 19 PEGS
- CUP SINK WITH COMPLETE SETS OF ACID RESISTANT P-TRAP AND DRAIN FITTINGS
- LAB GOOSENECK FAUCET WITH ISOLATION VALVE, FOR COLD WATER ONLY
- GAS OUTLETS WITH 2-WAY NOZZLE
- 2 ELECTRICAL OUTLET 110/220VAC
- 2 ELECTRICAL OUTLET 110/220VAC
- GAS OUTLETS WITH 2-WAY NOZZLE
- LAB GOOSENECK FAUCET WITH ISOLATION VALVE, FOR COLD WATER ONLY
- CUP SINK WITH COMPLETE SETS OF ACID RESISTANT P-TRAP AND DRAIN FITTINGS


PROJECT TITLE:	REQUESTING OFFICE:	REVIEWED BY:	RECOMMENDING APPROVAL:	RECOMMENDING APPROVAL:	APPROVED:	CHECKED:	SHEET CONTENTS:	SHEET NO.:
PROJECT LOCATION:	DR. MARY JANE N. RIGOR DEAN, COS	ENGR. RYAN M. LAYUG FDMO-PMU, HEAD	AR. FERDINAND S. VALENCIA FMDO, DIRECTOR	DR. MARLON V. GAMIDO VP ADMIN AND FINANCE	DR. MYRNA Q. MALLARI PRESIDENT	AR. FERDINAND S. VALENCIA ARCHITECTURAL	AS SHOWN	
COLLEGE OF SCIENCE, LUCINDA EXTENSION CAMPUS						MR. MARK ANTHONY PUNZALAN DRAFTSMAN	DATE: OCTOBER 2021	PAGE NO.:

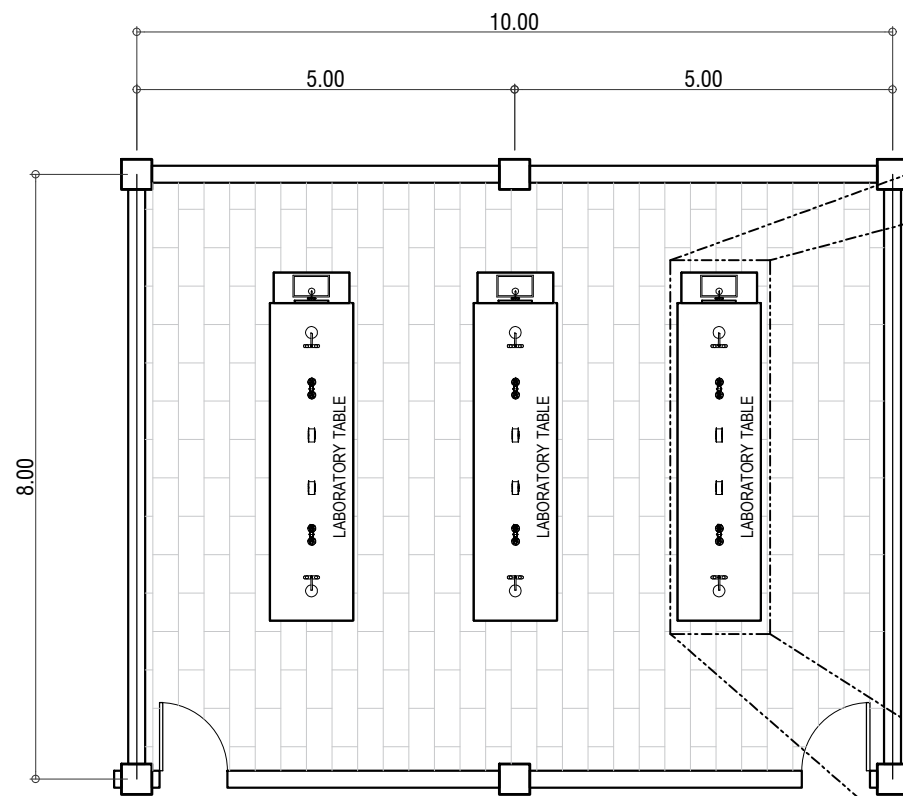

L.S 9 FLOOR PLAN
SCALE 1:100 MTS

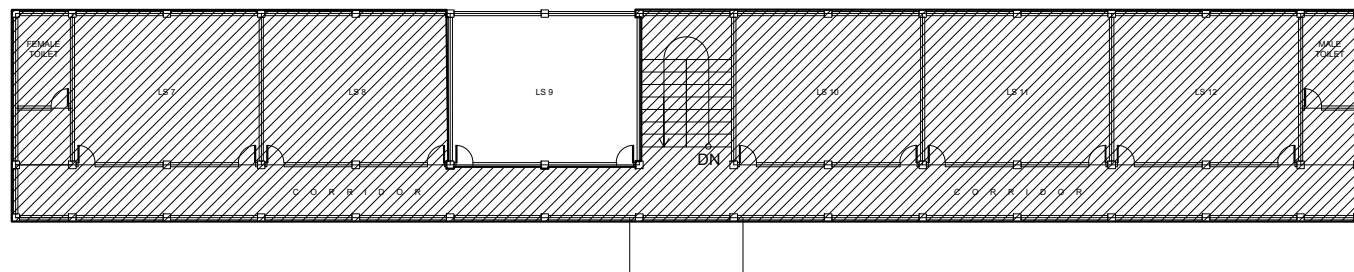

KEY PLAN
SCALE 1:400 MTS

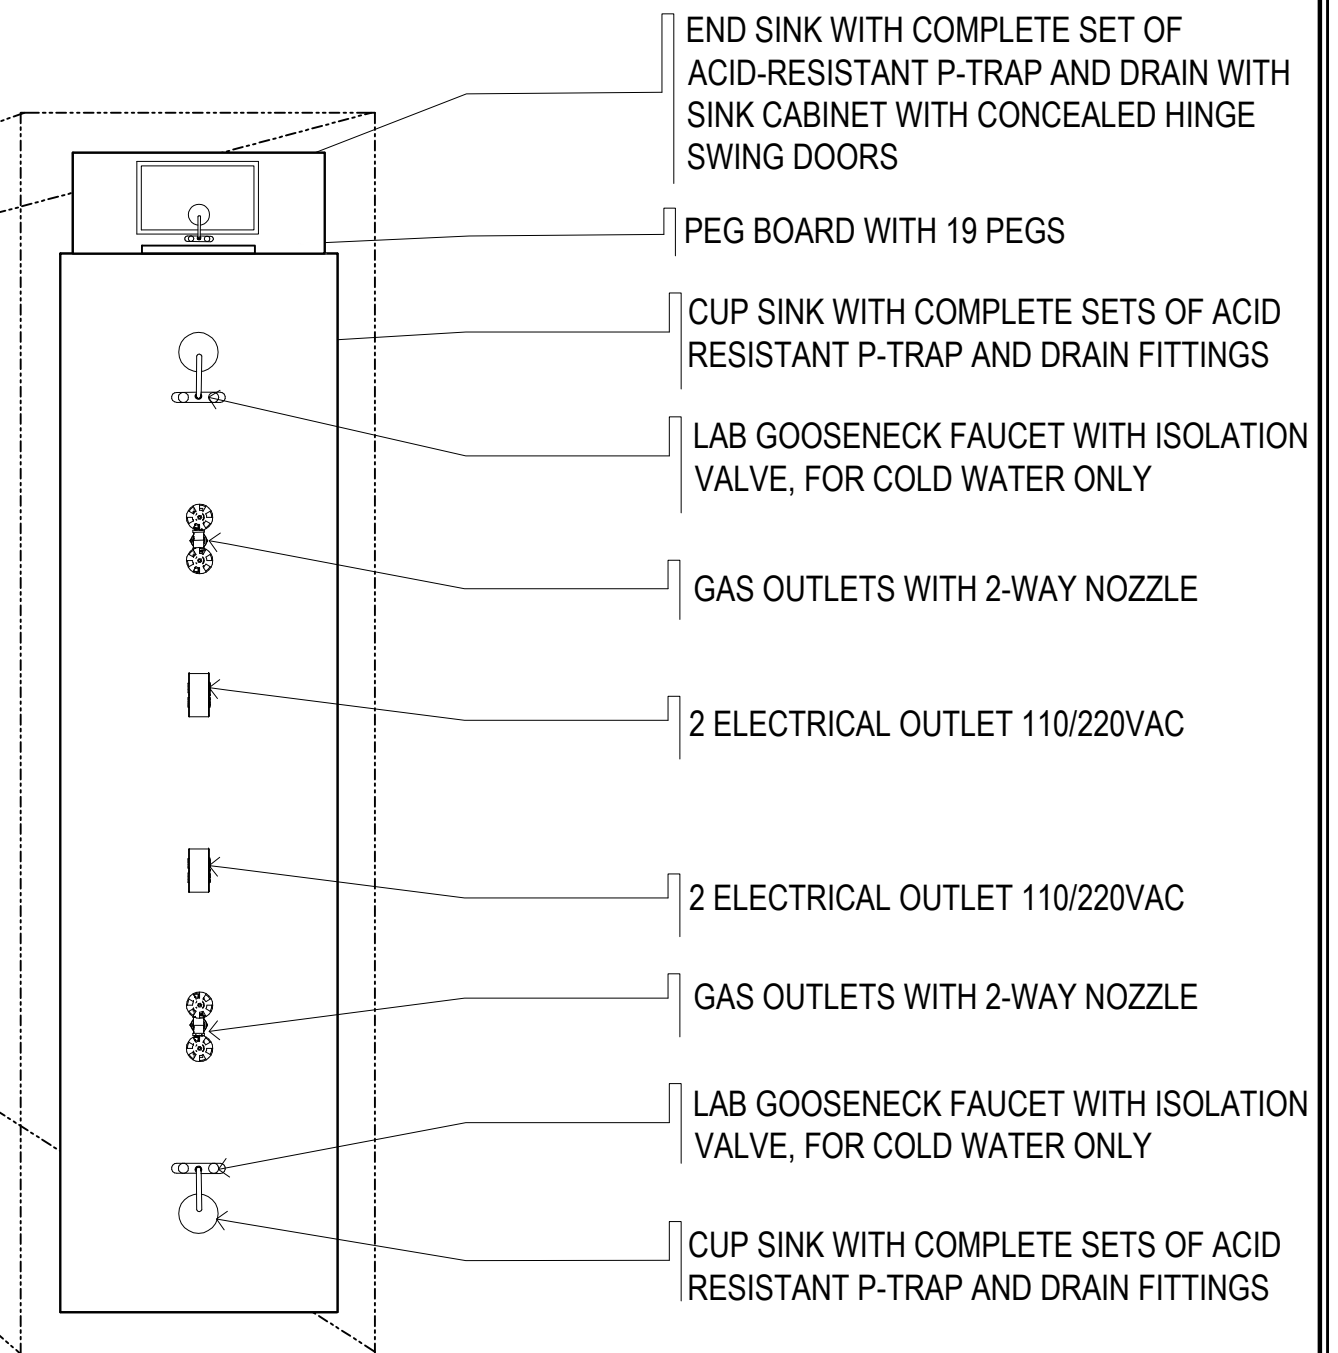


TYPICAL LABORATORY TABLE BLOW UP PLAN
SCALE 1:30 MTS



TARLAC STATE UNIVERSITY
Facilities Development and Management Office
Romulo Boulevard, Tarlac City, Philippines 2300

PROJECT TITLE:	REQUESTING OFFICE:	REVIEWED BY:	RECOMMENDING APPROVAL:	RECOMMENDING APPROVAL:	APPROVED:	CHECKED:	SHEET CONTENTS:	SHEET NO.:
PROJECT LOCATION:	DR. MARY JANE N. RIGOR DEAN, COS	ENGR. RYAN M. LAYUG FDMO-PMU, HEAD	AR. FERDINAND S. VALENCIA FMDO, DIRECTOR	DR. MARLON V. GAMIDO VP ADMIN AND FINANCE	DR. MYRNA Q. MALLARI PRESIDENT	AR. FERDINAND S. VALENCIA ARCHITECTURAL	AS SHOWN	
COLLEGE OF SCIENCE, LUCINDA EXTENSION CAMPUS						MR. MARK ANTHONY PUNZALAN DRAFTSMAN	DATE: OCTOBER 2021	PAGE NO.:

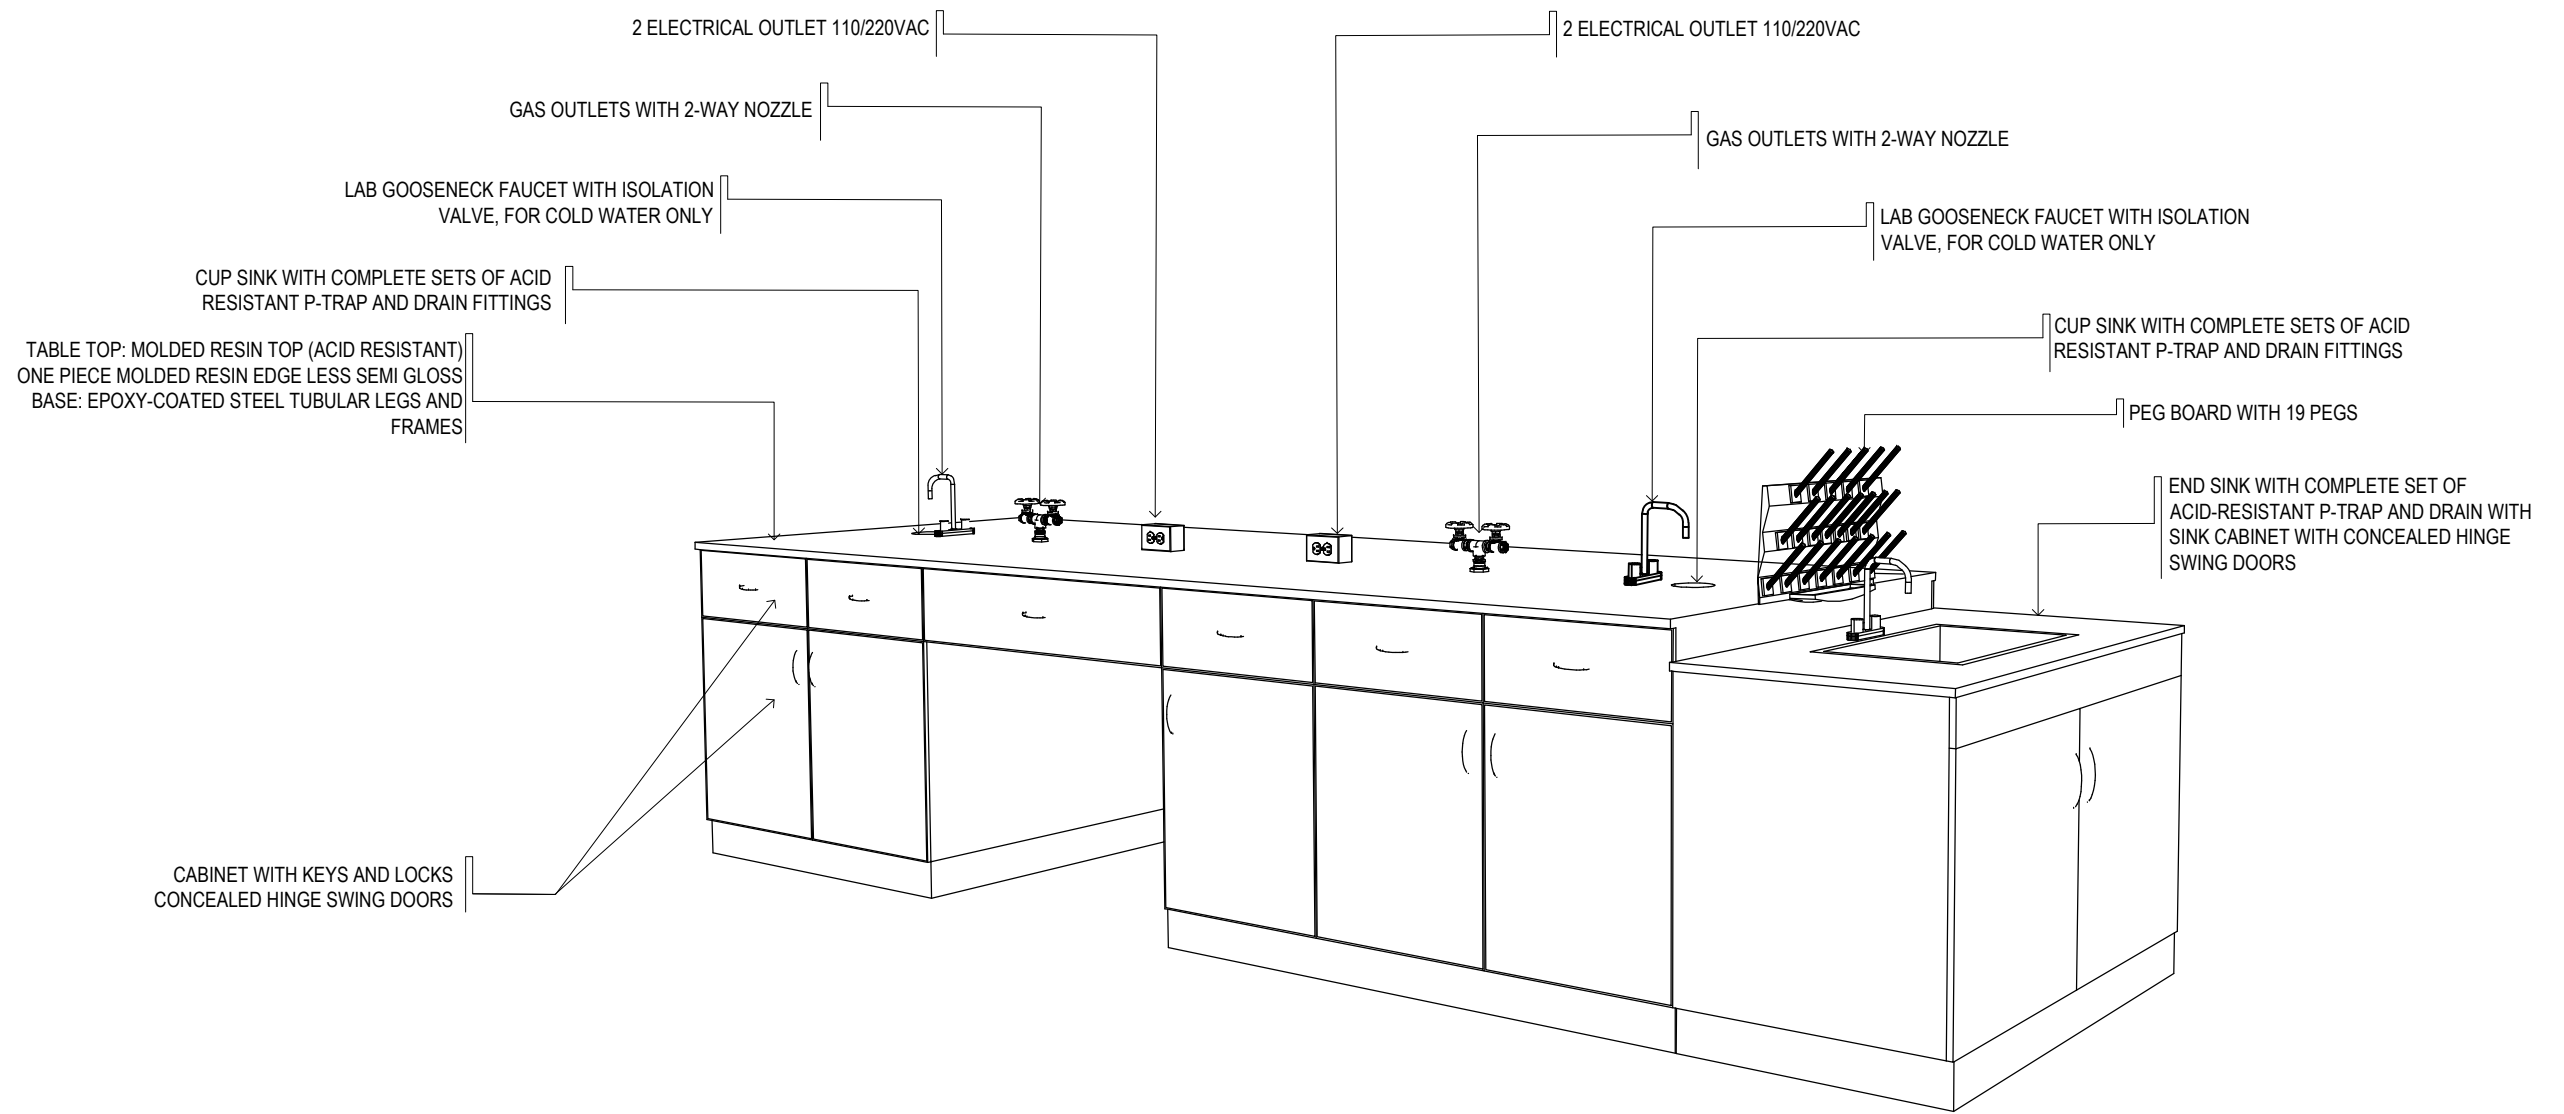

TYPICAL LABORATORY TABLE DETAIL
 SCALE _____ NTS

 TARLAC STATE UNIVERSITY Facilities Development and Management Office <small>Romulo Boulevard, Tarlac City, Philippines 2300</small>	PROJECT TITLE:	REQUESTING OFFICE:	REVIEWED BY:	RECOMMENDING APPROVAL:	RECOMMENDING APPROVAL:	APPROVED:	CHECKED:	SHEET CONTENTS:	SHEET NO.:	
	PROJECT LOCATION:	DR. MARY JANE N. RIGOR DEAN, COS	ENGR. RYAN M. LAYUG FDMO-PMU, HEAD	AR. FERDINAND S. VALENCIA FDMO, DIRECTOR	DR. MARLON V. GAMIDO VP ADMIN AND FINANCE	DR. MYRNA Q. MALLARI PRESIDENT	AR. FERDINAND S. VALENCIA ARCHITECTURAL	AS SHOWN	DATE: OCTOBER 2021	PAGE NO.:
	COLLEGE OF SCIENCE, LUCINDA EXTENSION CAMPUS						MR. MARK ANTHONY PUNZALAN DRAFTSMAN			PAGE NO.: